


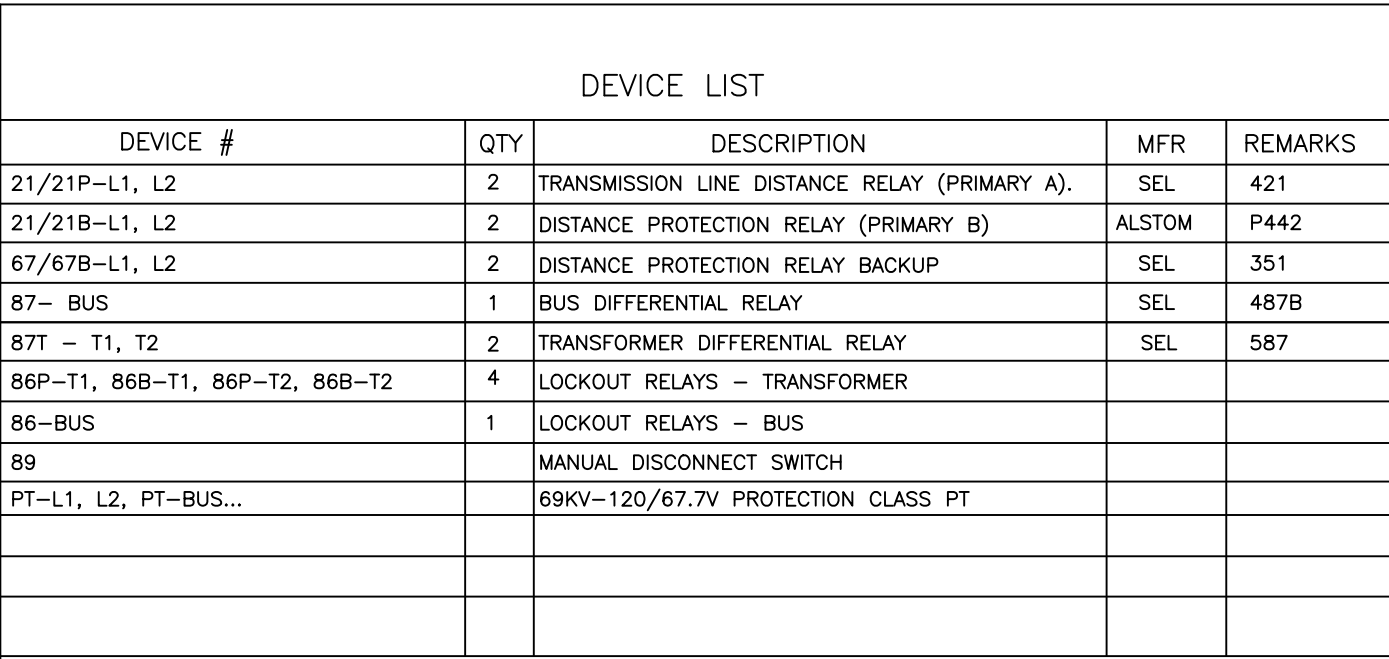

REFERENCE DRAWINGS	
DRAWING #	DESCRIPTION

	CIRCUIT BREAKER
	DISTRIBUTION - MAIN CIRCUIT BREAKER
	SURGE ARRESTER
	FUSE
	TRANSFORMER
	BUSHING C.T.
	P.T.
	DISCONNECT SWITCH
	MOTORISED DISCONNECT
	F.T. SWITCH
	FUTURE INSTALLATION
	DIGITAL FAULT RECORDER
	SPLIT CORE CURRENT TRANSF. TO BE DISTRIBUTED IN PANELS

NOTES:

1. PROTECTION DEVICE BEING PROCURED UNDER THE PROTECTION PANEL PROCUREMENT FOR WASHINGTON BLVD, CANE RIVER AND ROCKFORT SUBSTATION PANEL REPLACEMENT PROJECT.

No.	PARTICULARS	APP.	BY	DATE

REVISION

JPS JAMAICA PUBLIC SERVICE CO. LTD.
KINGSTON JAMAICA

CANE RIVER 69/24KV SUBSTATION
PROTECTION & METERING SINGLE LINE DIAGRAM

DWG. SCALE: NTS	DESIGNED BY: A.T.LEE	DATES: 09/05/2025	DRAWING NO. CRV_SLD_001
PLOT SCALE:	DRAWN BY: A. T. LEE	09/05/2025	
SUPSEDES:	CHECKED BY:		
DATE:	APPROVED BY:		
			PROJECT No: N-1