


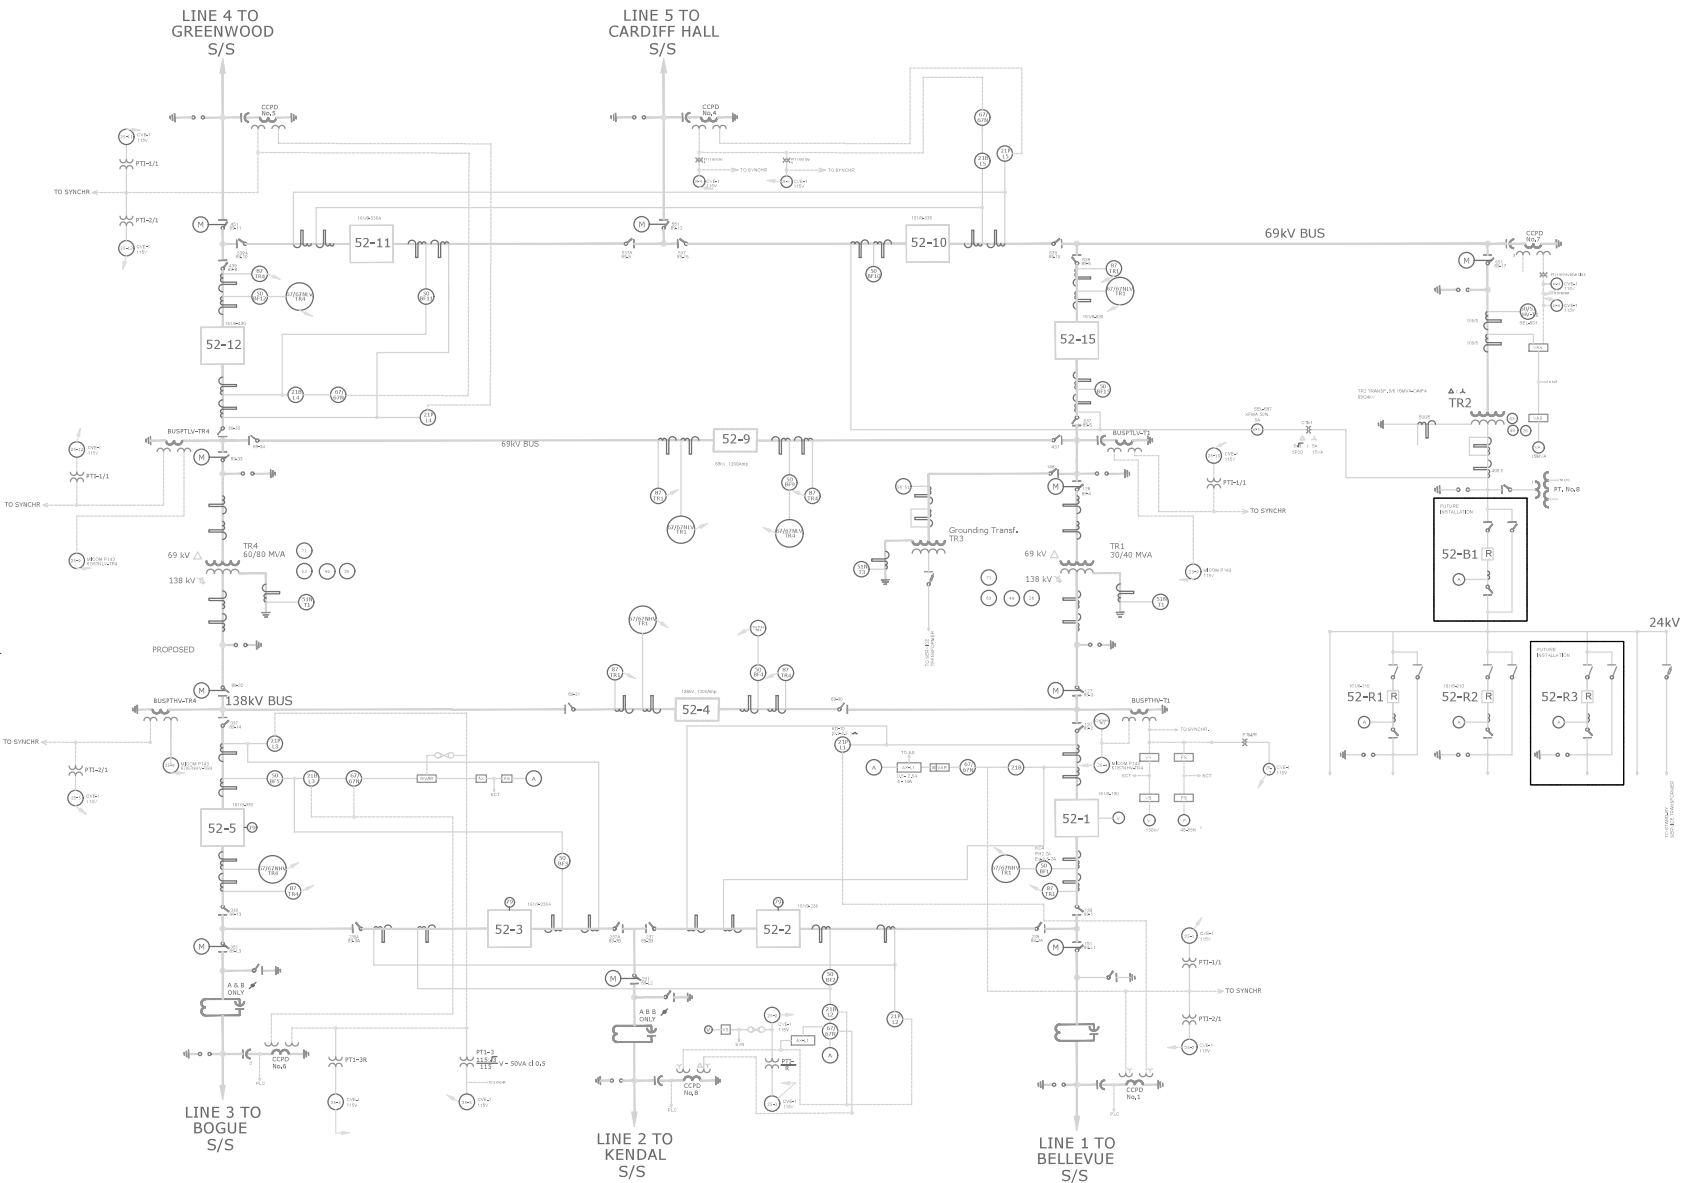

GENERAL NOTES

REFERENCE DRAWINGS

DRAWING No.	DESCRIPTION	REV No.	REVISION
405 00157 E	ONE LINE DIAGRAM		
405 00158 C	SCHEMATIC DIAGRAM		
405 00159 C	TERMINAL BOARD		
405 00260 E	CONTROL PANEL, OUT - LINE		
405 00261 F	CONTROL PANEL, WINDING DIAGRAM		
405 00262 E	RELAY PANEL, OUT - LINE		
405 00263 F	RELAY PANEL, WINDING DIAGRAM		
405 00264	CABLE LIST		

NO.	PARTICULARS	APP. BY	DATE
	REVISIONS		
	JAMAICA PUBLIC SERVICE CO. LTD.		
	KINGSTON JAMAICA		
	DUNCANS SUBSTATION		
	ONE LINE DIAGRAM		

MANUFACTURE: ANSALDO	APPROVED BY:	DATE:	DRAWING NO./REV. No.
MANUFACTURE DWG. No.: S054.SS.825.088/01	DESIGNED BY:	18744	3
	DRAWN BY:	125	REF.
SYSTEM No.:	CHECKED BY:	No.	ISO 282500